







OWNER:  شرکت سست و سویی توسعه ایرانلیان (سهامی منتهی الیه)	BUSHEHR PETROCHEMICAL COMPANY MEG PLANT							EPC CONTRACTOR:  Chagalesh-Enerchimi-Steam Joint Venture BUPC-MEG PLANT PROJECT	
	LOOP DIAGRAM FOR EMERGENCY INSTRUMENT AIR COMPRESSOR								
MC :  شرکت سست و سویی توسعه ایرانلیان (سهامی منتهی الیه)	Project	Area	Phase	Unit	Dis.	Doc.	Seq.	Contract No : 52-98/445	
Owner Document Number: 17811-30B	BU	20	VD	303	IN	DIG	0086	Rev.:	Page
								01	1 of 24

LOOP DIAGRAM FOR EMERGENCY INSTRUMENT AIR COMPRESSOR

 شرکت سست و سویی توسعه ایرانلیان (سهامی منتهی الیه)	 Chagalesh-Enerchimi-Steam Joint Venture BUPC-MEG PLANT PROJECT	BUSHEHR PETROCHEMICAL COMPANY MEG PLANT
Document Review		
Issue Purpose:	IFA	
Result Code: AP,AN,CM,RE,NC	AP	
Next Status : IFC,IFA,IFI,AFC,AB	AFC	
Responsible Department	MECHANICAL	
Commented Date	7/24/2022	

Approval or review hereunder shall not be construed to relieve Vendor / Subcontractor of his responsibilities and liability under the contract.						
01	15/07/2022	For approval	MG	RB	KP	
00	18/10/2021	For approval	HT	KP	JR	
Rev.	Date	Purpose of Issue	Prepared	Checked	Approved	AC Code
					Class: 1	Phase: P



Airpack B.V.

4301 RN Zierikzee
The Netherlands

PHONE: (31) (0) 111 - 415455

FAX: (31) (0) 111 - 413338

E-MAIL : AIRPACK@AIRPACK.NL

WEBPAGE : WWW.AIRPACK.NL

Client : Bushehr Petrochemical Company (BUPC)

Equipment location : Iran, Onshore

Client reference : Bushehr MEG Plant Project

Client dwg. no. : BU-20-VD-303-IN-DIG-0093

Airpack reference : 17811-30B

Airpack dwg. no. : 17811-05B

Generation date : 30-6-2021

E & I manager : RBE

Last modifications : 14-7-2022

Last modifications by : MaGo

Revision no. : 01



CLIENT DWG NO.	BU-20-VD-303-IN-DIG-0093
EQUIPMENT NO.	20-C-7080
EQUIPMENT LOCATION	Iran, Onshore


THIS DRAWING IS OWNED BY AIRPACK, AND SHALL NOT BE PRINTED OR COPIED IN ANY OTHER WAY THAN WITH AIRPACKS PERMISSION!

SUBJECT Title page / cover sheet	
ADAPTED TO P&ID REVISION	05
CLIENT	Bushehr Petrochemical Company (BUPC)
CLIENT REF.	Bushehr MEG Plant Project
AIRPACK REF.	17811-30B


DRAWN BY	MaGo	=
CHECKED BY	RBE	+
LAST MODIFICATION DATE		
AIRPACK DWG NO.	17811-05B	
REVISION	01	
TOTAL PAGE AMOUNT	1	

CURRENT PAGE


Internal targets

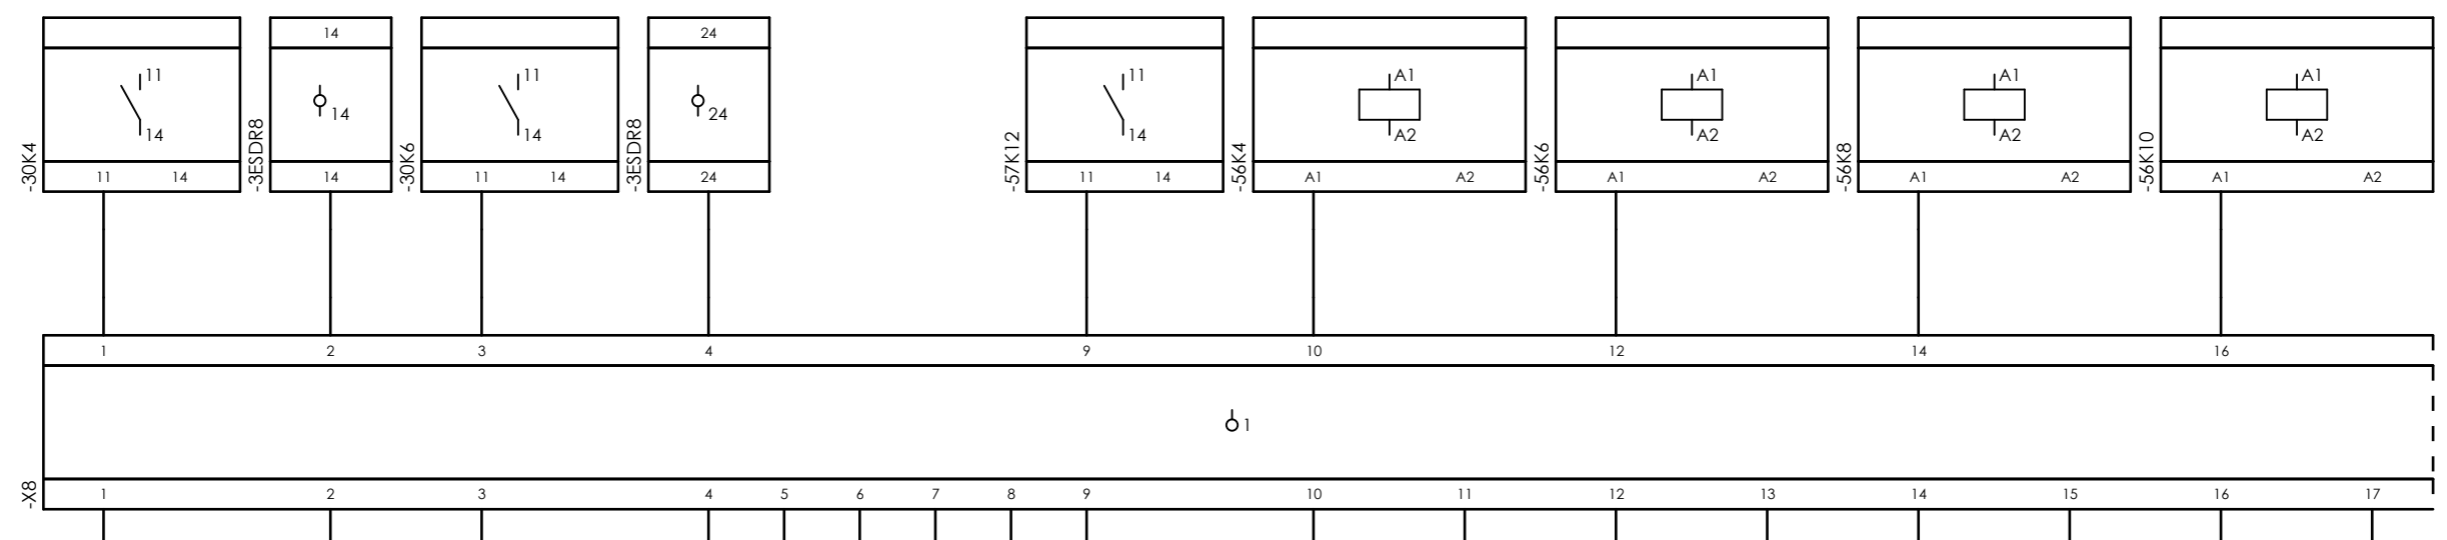

=20-C-7080+UCP-C7080-01-DB_COMB

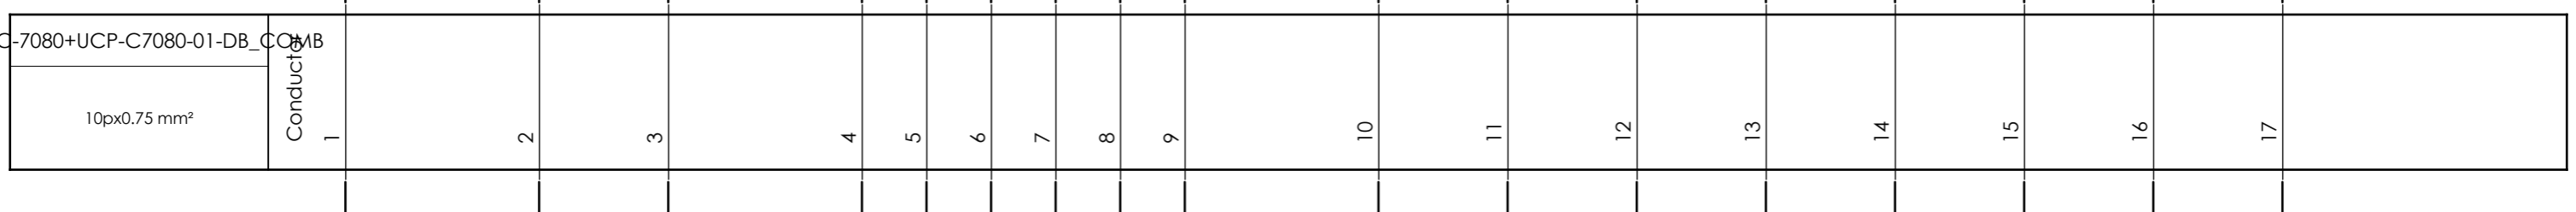

External targets

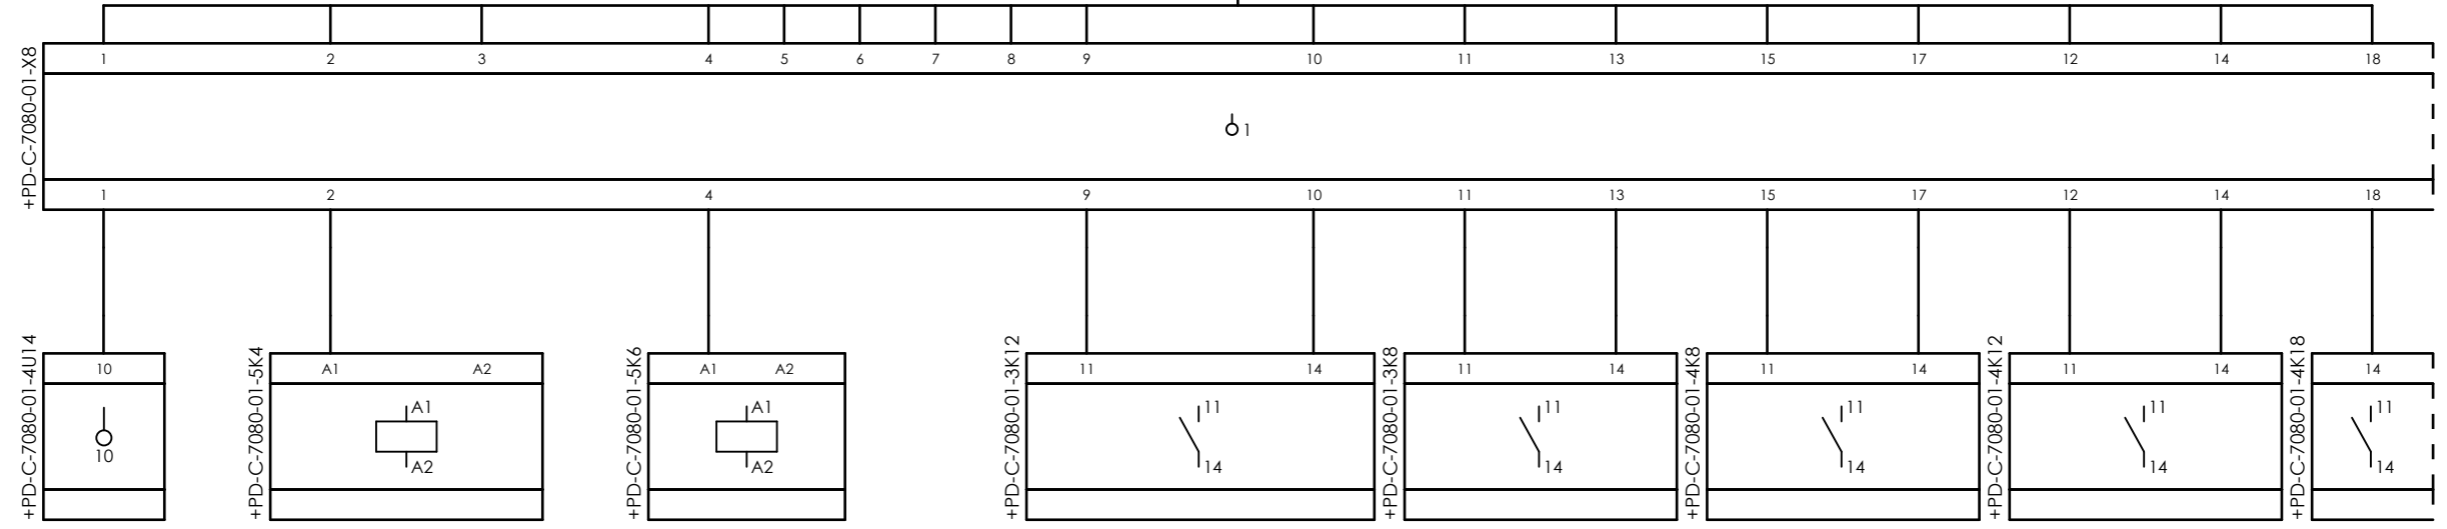


CLIENT DWG NO.	BU-20-VD-303-IN-DIG-0093
EQUIPMENT NO.	20-C-7080
EQUIPMENT LOCATION	Iran, Onshore
THIS DRAWING IS OWNED BY AIRPACK, AND SHALL NOT BE PRINTED OR COPIED IN ANY OTHER WAY THAN WITH AIRPACKS PERMISSION!	

SUBJECT		Cable-connection diagram =20-C-7080+UCP-C7080-01-DB_COMB	
ADAPTED TO P&ID REVISION	05		
CLIENT	Bushehr Petrochemical Company (BUPC)		
CLIENT REF.	Bushehr MEG Plant Project		
AIRPACK REF.	17811-30B		

DRAWN BY	MaGo	=
CHECKED BY	RBE	+
LAST MODIFICATION DATE		CURRENT PAGE
AIRPACK DWG NO.	17811-05B	
REVISION	01	
TOTAL PAGE AMOUNT	2	


Internal targets

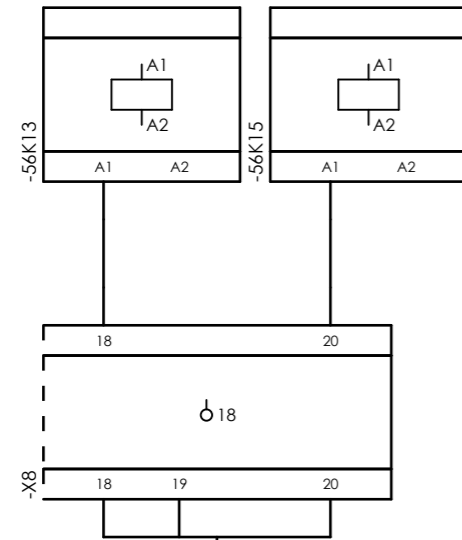

=20-C-7080+UCP-C7080-01-DB_COMB



External targets

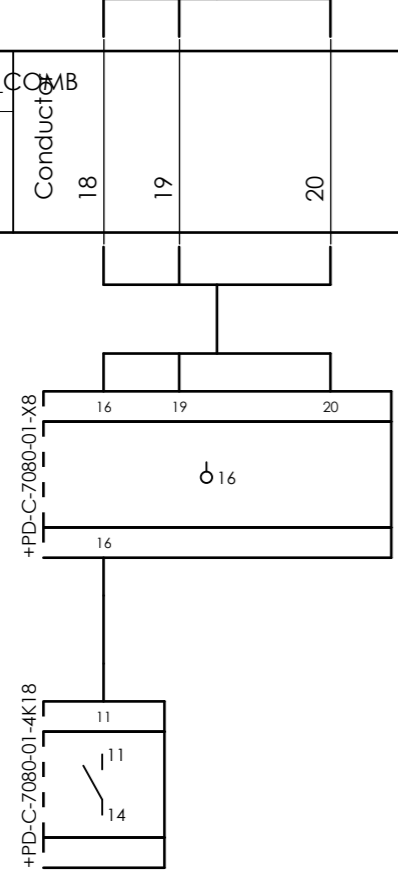


CLIENT DWG NO.	BU-20-VD-303-IN-DIG-0093
EQUIPMENT NO.	20-C-7080
EQUIPMENT LOCATION	Iran, Onshore
THIS DRAWING IS OWNED BY AIRPACK, AND SHALL NOT BE PRINTED OR COPIED IN ANY OTHER WAY THAN WITH AIRPACKS PERMISSION!	

SUBJECT		Cable-connection diagram =20-C-7080+UCP-C7080-01-DB_COMB	
ADAPTED TO P&ID REVISION	05	CLIENT	Bushehr Petrochemical Company (BUPC)
CLIENT REF.	Bushehr MEG Plant Project	AIRPACK REF.	17811-30B

DRAWN BY	MaGo
CHECKED BY	RBE
LAST MODIFICATION DATE	
AIRPACK DWG NO.	17811-05B
REVISION	01
TOTAL PAGE AMOUNT	3



=	
+	
CURRENT PAGE	

Internal targets




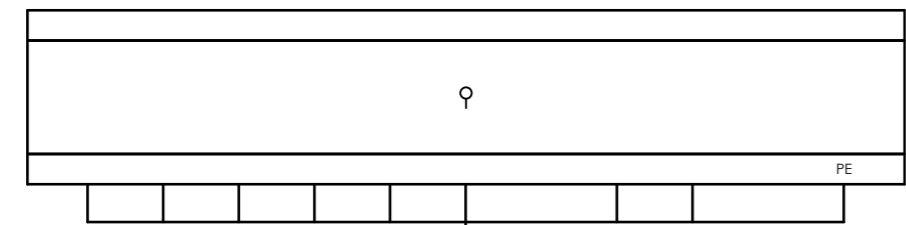


=20-C-7080+UCP-C7080-01-ESD

5Px0,75 mm² mm²

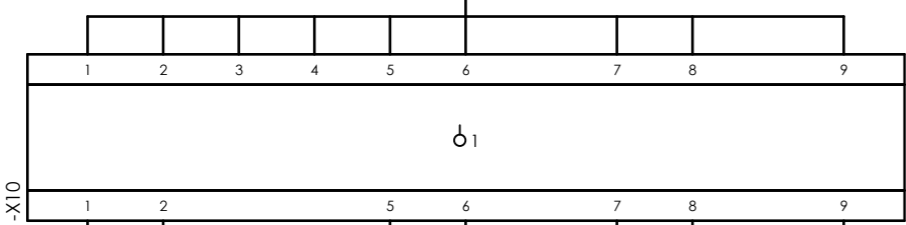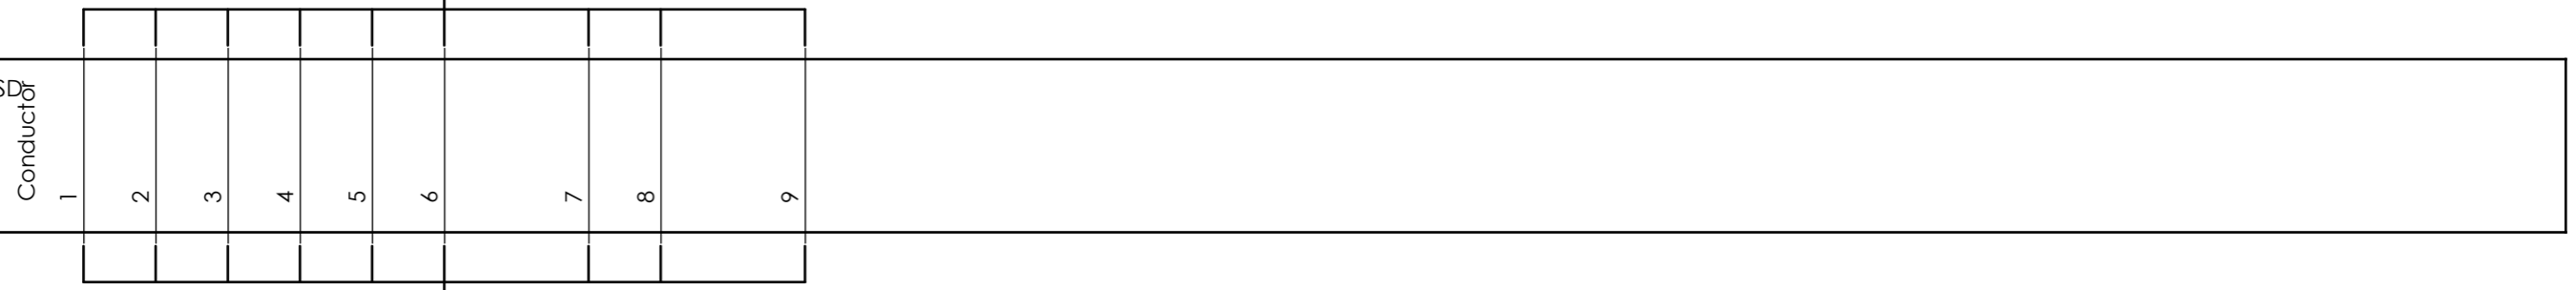

External targets

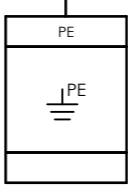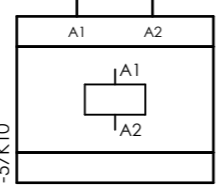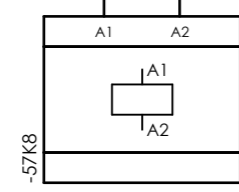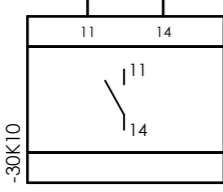


CLIENT DWG NO. BU-20-VD-303-IN-DIG-0093
 EQUIPMENT NO. 20-C-7080
 EQUIPMENT LOCATION Iran, Onshore
 THIS DRAWING IS OWNED BY AIRPACK, AND SHALL NOT BE PRINTED OR COPIED IN ANY OTHER WAY THAN WITH AIRPACKS PERMISSION!

SUBJECT Cable-connection diagram =20-C-7080+UCP-C7080-01-ESD
 ADAPTED TO P&ID REVISION 05
 CLIENT Bushehr Petrochemical Company (BUPC)
 CLIENT REF. Bushehr MEG Plant Project
 AIRPACK REF. 17811-30B

DRAWN BY MaGo
 CHECKED BY RBE
 LAST MODIFICATION DATE
 AIRPACK DWG NO. 17811-05B
 REVISION 01
 TOTAL PAGE AMOUNT 4

=
 +
 CURRENT PAGE


Internal targets

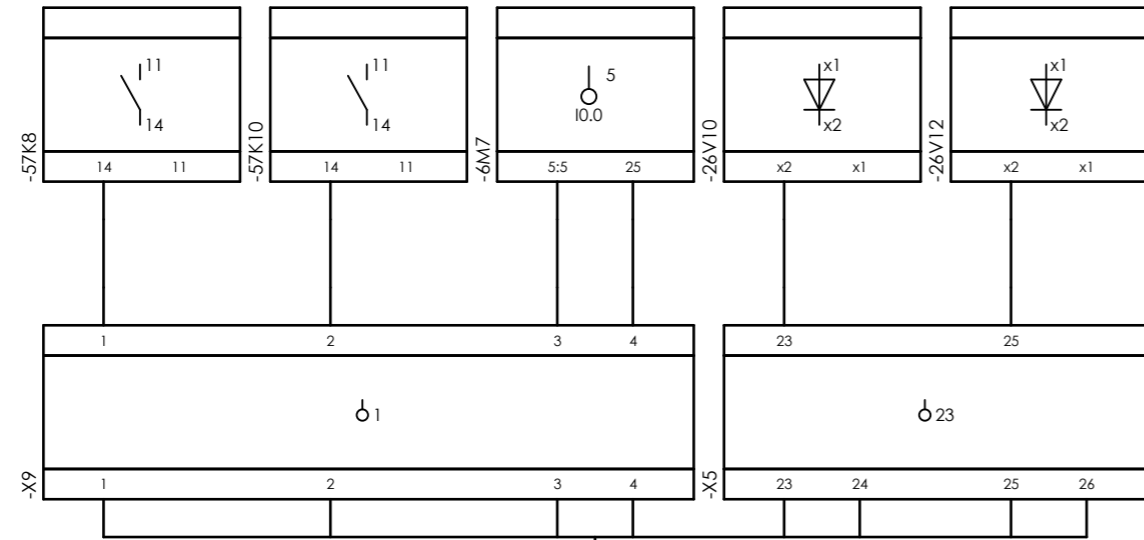

=20-C-7080+UCP-C7080-01-ESD_LCP_B




External targets


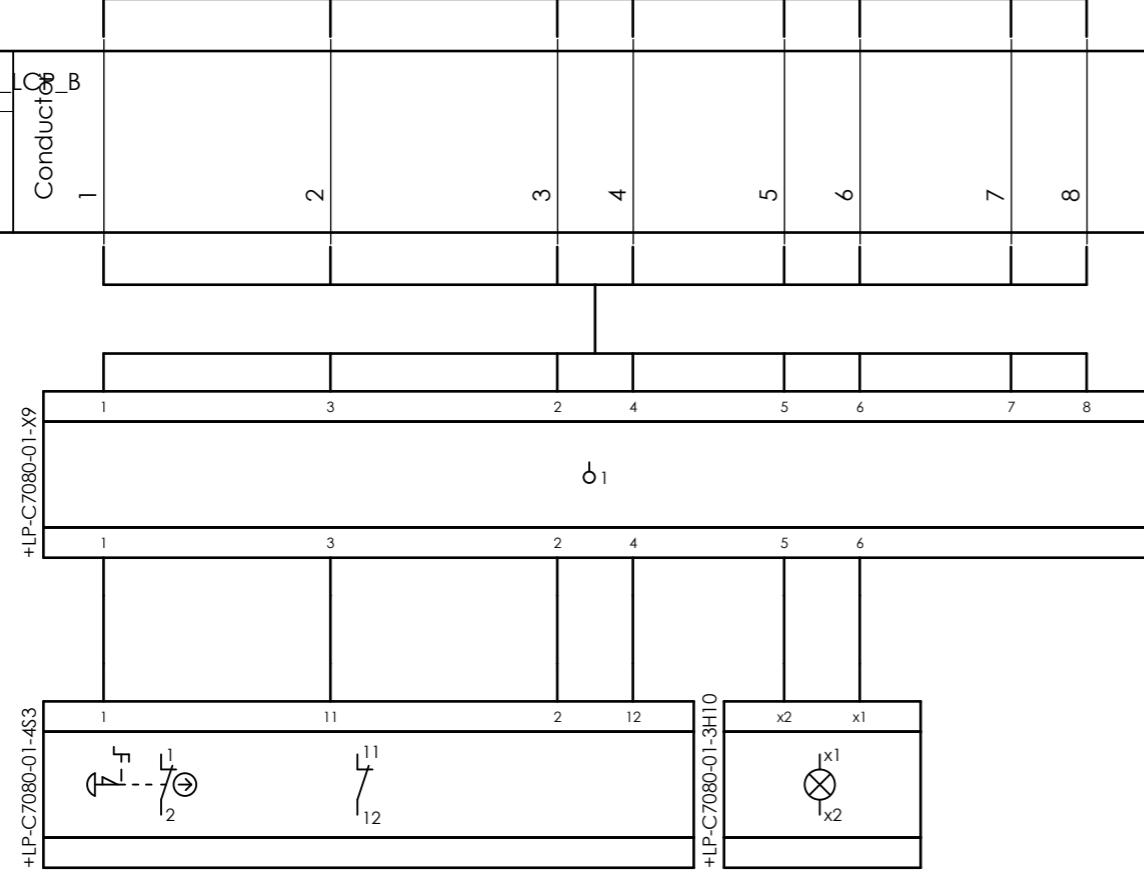


CLIENT DWG NO.	BU-20-VD-303-IN-DIG-0093	SUBJECT		DRAWN BY	MaGo	=
EQUIPMENT NO.	20-C-7080	Cable-connection diagram =20-C-7080+UCP-C7080-01-ESD_LCP_B		CHECKED BY	RBE	+
EQUIPMENT LOCATION	Iran, Onshore	ADAPTED TO P&ID REVISION	05	LAST MODIFICATION DATE		CURRENT PAGE
THIS DRAWING IS OWNED BY AIRPACK, AND SHALL NOT BE PRINTED OR COPIED IN ANY OTHER WAY THAN WITH AIRPACKS PERMISSION!	CLIENT	Bushehr Petrochemical Company (BUPC)		AIRPACK DWG NO.	17811-05B	
	CLIENT REF.	Bushehr MEG Plant Project		REVISION	01	
	AIRPACK REF.	17811-30B		TOTAL PAGE AMOUNT	5	


Internal targets

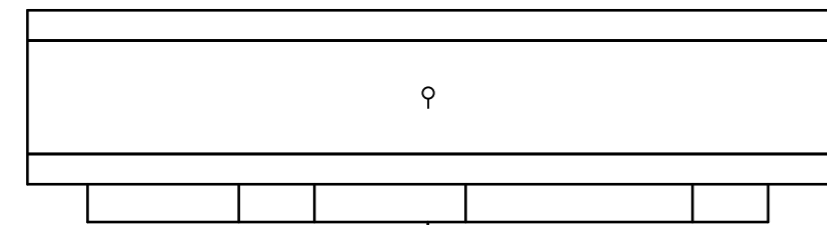

=20-C-7080+UCP-C7080-01-FCS
10Px0,75 mm²
Conductors

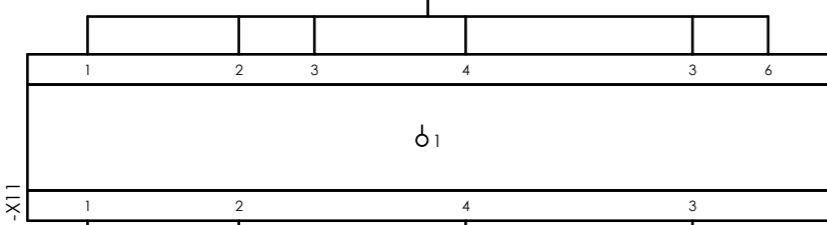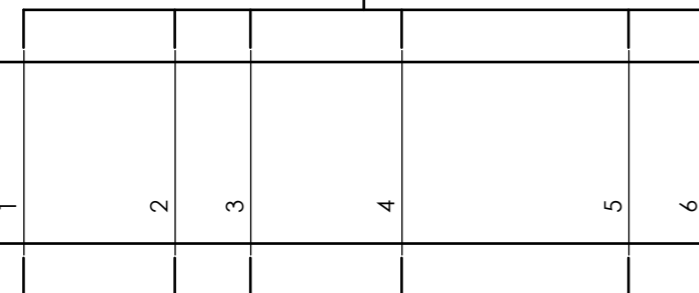


External targets

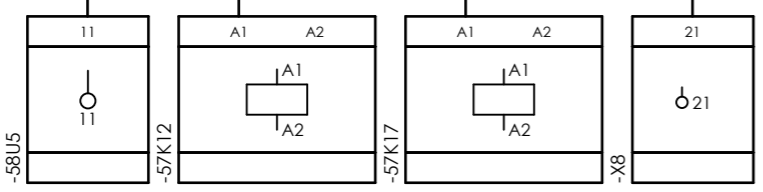


CLIENT DWG NO.	BU-20-VD-303-IN-DIG-0093
EQUIPMENT NO.	20-C-7080
EQUIPMENT LOCATION	Iran, Onshore
THIS DRAWING IS OWNED BY AIRPACK, AND SHALL NOT BE PRINTED OR COPIED IN ANY OTHER WAY THAN WITH AIRPACKS PERMISSION!	

SUBJECT		DRAWN BY	MaGo	=
Cable-connection diagram =20-C-7080+UCP-C7080-01-FCS		CHECKED BY	RBE	+
ADAPTED TO P&ID REVISION	05	LAST MODIFICATION DATE		CURRENT PAGE
CLIENT	Bushehr Petrochemical Company (BUPC)	AIRPACK DWG NO.	17811-05B	
CLIENT REF.	Bushehr MEG Plant Project	REVISION	01	
AIRPACK REF.	17811-30B	TOTAL PAGE AMOUNT	6	


Internal targets

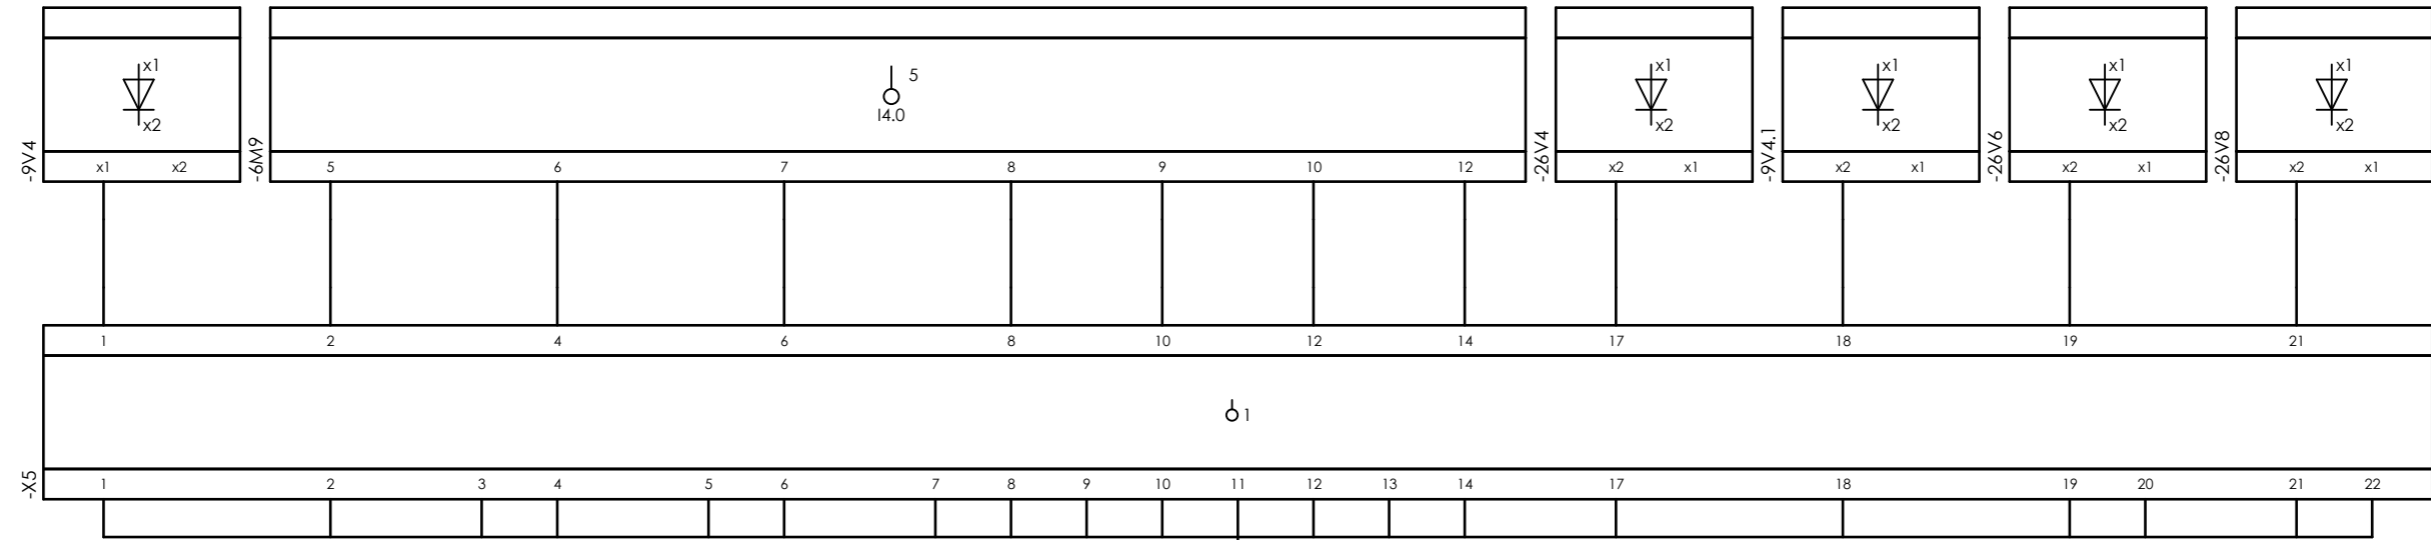

=20-C-7080+UCP-C7080-01-LCP_COMB

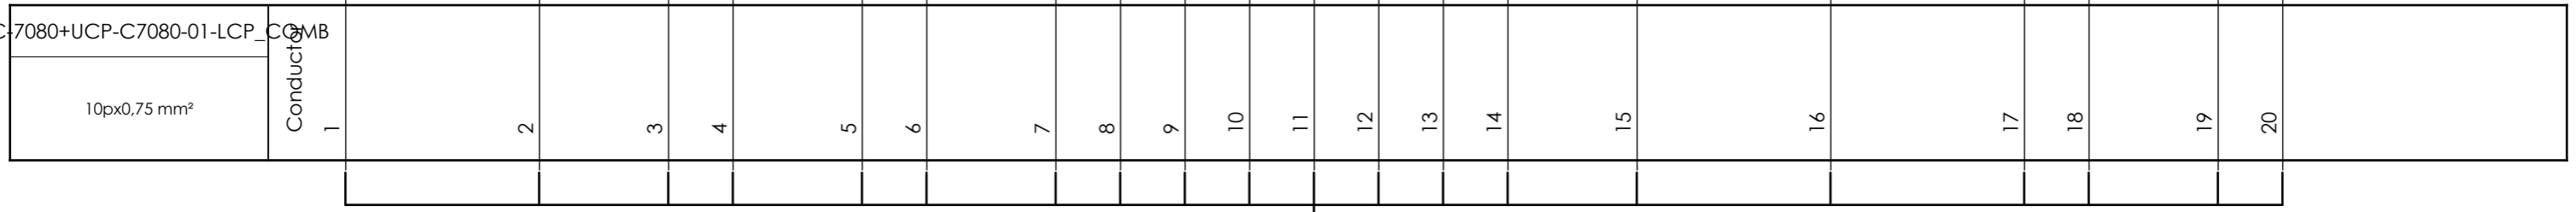

External targets

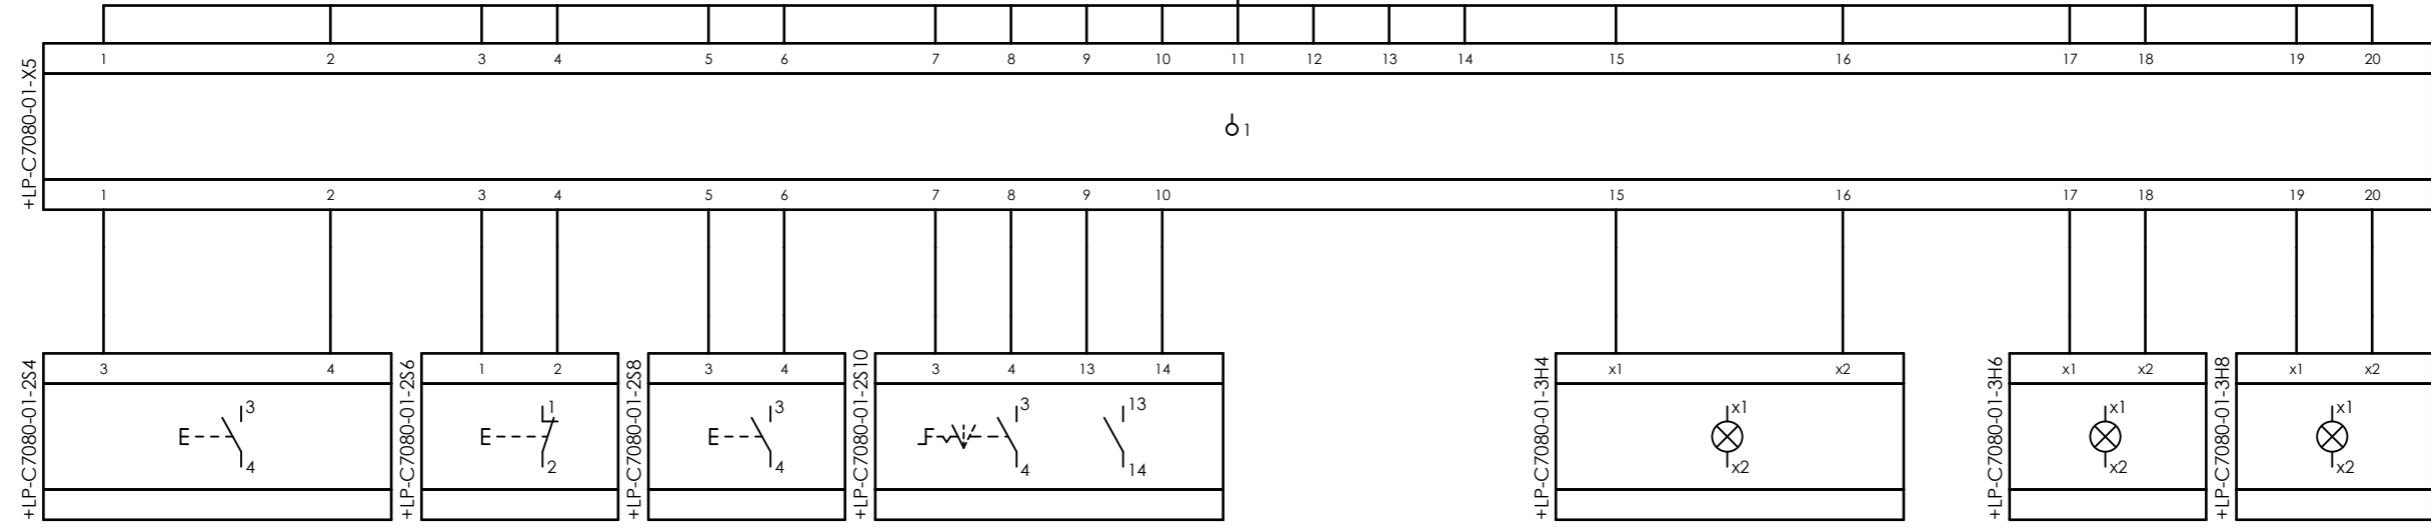


CLIENT DWG NO. BU-20-VD-303-IN-DIG-0093
 EQUIPMENT NO. 20-C-7080
 EQUIPMENT LOCATION Iran, Onshore
 THIS DRAWING IS OWNED BY AIRPACK, AND SHALL NOT BE PRINTED OR COPIED IN ANY OTHER WAY THAN WITH AIRPACKS PERMISSION!

SUBJECT Cable-connection diagram =20-C-7080+UCP-C7080-01-LCP_COMB
 ADAPTED TO P&ID REVISION 05
 CLIENT Bushehr Petrochemical Company (BUPC)
 CLIENT REF. Bushehr MEG Plant Project
 AIRPACK REF. 17811-30B

DRAWN BY MaGo
 CHECKED BY RBE
 LAST MODIFICATION DATE
 AIRPACK DWG NO. 17811-05B
 REVISION 01
 TOTAL PAGE AMOUNT 7

=
 +
 CURRENT PAGE


Internal targets

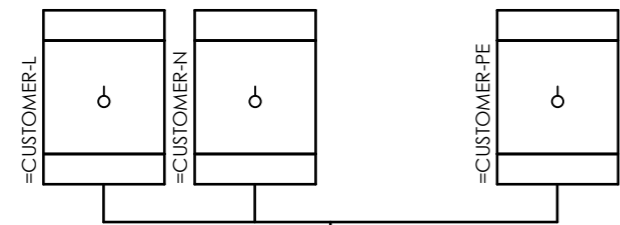

=20-C-7080+UCP-C7080-01-PS_00



External targets

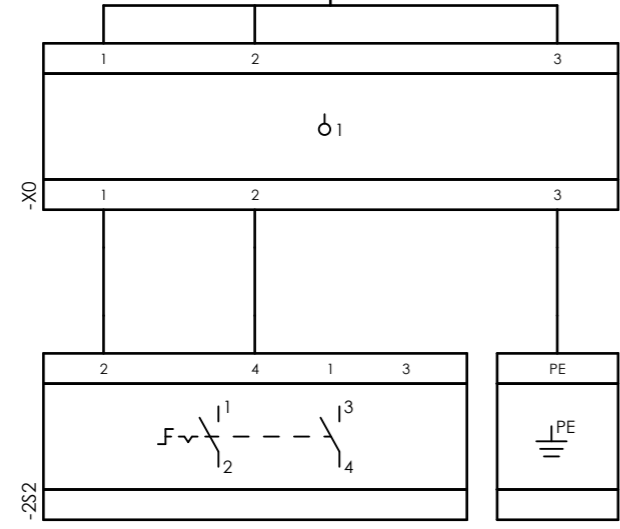


CLIENT DWG NO.	BU-20-VD-303-IN-DIG-0093
EQUIPMENT NO.	20-C-7080
EQUIPMENT LOCATION	Iran, Onshore
THIS DRAWING IS OWNED BY AIRPACK, AND SHALL NOT BE PRINTED OR COPIED IN ANY OTHER WAY THAN WITH AIRPACKS PERMISSION!	

SUBJECT		Cable-connection diagram =20-C-7080+UCP-C7080-01-PS_00	
ADAPTED TO P&ID REVISION	05	CLIENT	Bushehr Petrochemical Company (BUPC)
CLIENT REF.	Bushehr MEG Plant Project	AIRPACK REF.	17811-30B

DRAWN BY	MaGo	=
CHECKED BY	RBE	+
LAST MODIFICATION DATE		CURRENT PAGE
AIRPACK DWG NO.	17811-05B	
REVISION	01	
TOTAL PAGE AMOUNT	8	


Internal targets

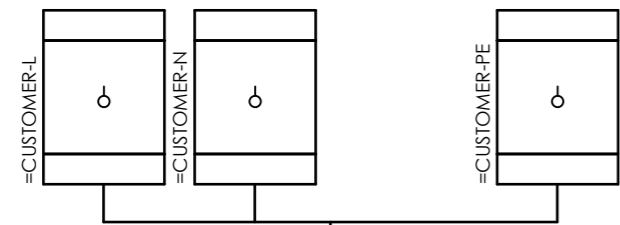

=20-C-7080+UCP-C7080-01-PS_01



External targets

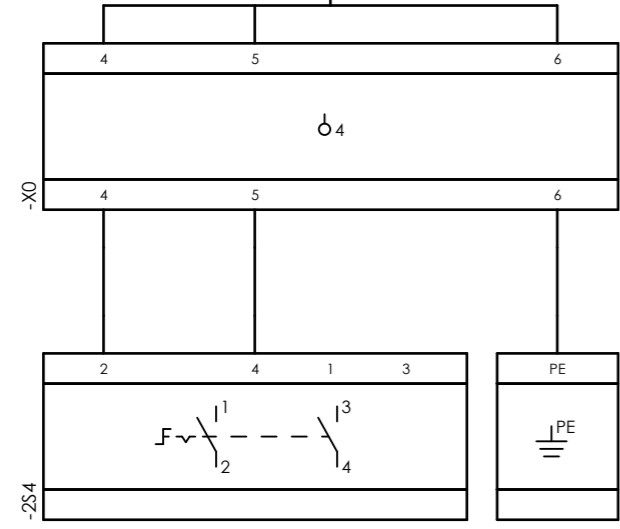


CLIENT DWG NO.	BU-20-VD-303-IN-DIG-0093
EQUIPMENT NO.	20-C-7080
EQUIPMENT LOCATION	Iran, Onshore
THIS DRAWING IS OWNED BY AIRPACK, AND SHALL NOT BE PRINTED OR COPIED IN ANY OTHER WAY THAN WITH AIRPACKS PERMISSION!	

SUBJECT		Cable-connection diagram =20-C-7080+UCP-C7080-01-PS_01	
ADAPTED TO P&ID REVISION	05	CLIENT	Bushehr Petrochemical Company (BUPC)
CLIENT REF.	Bushehr MEG Plant Project	AIRPACK REF.	17811-30B


DRAWN BY	MaGo
CHECKED BY	RBE
LAST MODIFICATION DATE	
AIRPACK DWG NO.	17811-05B
REVISION	01
TOTAL PAGE AMOUNT	9

=	
+	
CURRENT PAGE	


Internal targets

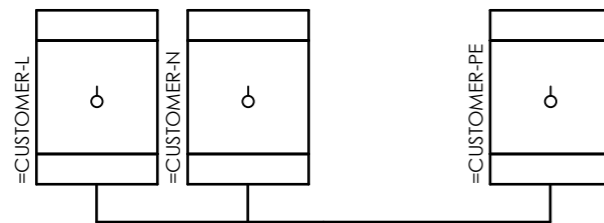

=20-C-7080+UCP-C7080-01-PS_02
3x2.5 sqmm

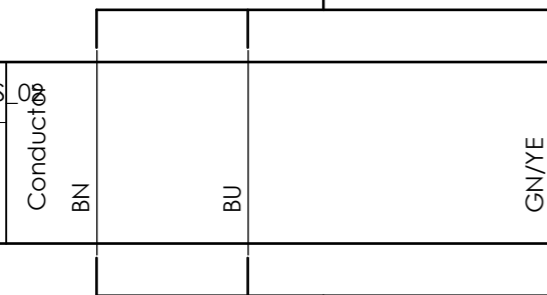

External targets


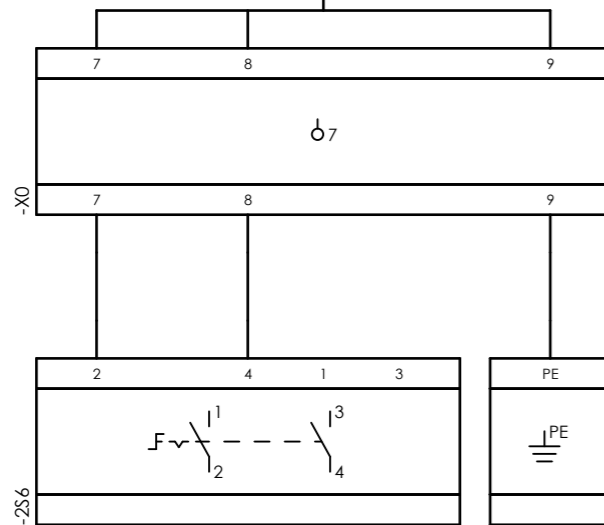


CLIENT DWG NO.	BU-20-VD-303-IN-DIG-0093
EQUIPMENT NO.	20-C-7080
EQUIPMENT LOCATION	Iran, Onshore
THIS DRAWING IS OWNED BY AIRPACK, AND SHALL NOT BE PRINTED OR COPIED IN ANY OTHER WAY THAN WITH AIRPACKS PERMISSION!	


SUBJECT		DRAWN BY	MaGo
Cable-connection diagram =20-C-7080+UCP-C7080-01-PS_02		CHECKED BY	RBE
ADAPTED TO P&ID REVISION	05	LAST MODIFICATION DATE	
CLIENT	Bushehr Petrochemical Company (BUPC)	AIRPACK DWG NO.	17811-05B
CLIENT REF.	Bushehr MEG Plant Project	REVISION	01
AIRPACK REF.	17811-30B	TOTAL PAGE AMOUNT	10

CURRENT PAGE	
--------------	--

Internal targets

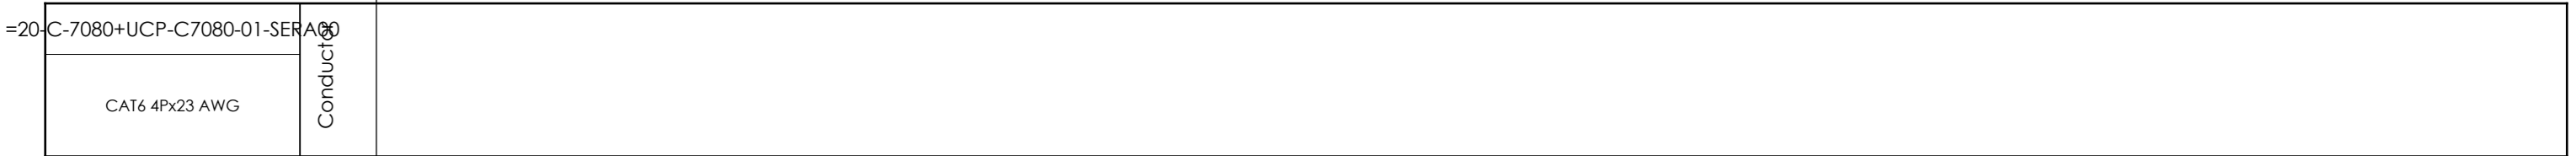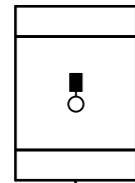

External targets

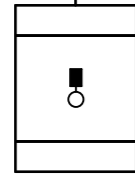


CLIENT DWG NO.	BU-20-VD-303-IN-DIG-0093
EQUIPMENT NO.	20-C-7080
EQUIPMENT LOCATION	Iran, Onshore
THIS DRAWING IS OWNED BY AIRPACK, AND SHALL NOT BE PRINTED OR COPIED IN ANY OTHER WAY THAN WITH AIRPACKS PERMISSION!	

SUBJECT Cable-connection diagram =20-C-7080+UCP-C7080-01-SERA00	
ADAPTED TO P&ID REVISION	05
CLIENT	Bushehr Petrochemical Company (BUPC)
CLIENT REF.	Bushehr MEG Plant Project
AIRPACK REF.	17811-30B

DRAWN BY	MaGo
CHECKED BY	RBE
LAST MODIFICATION DATE	
AIRPACK DWG NO.	17811-05B
REVISION	01
TOTAL PAGE AMOUNT	11

=
+
CURRENT PAGE

Internal targets

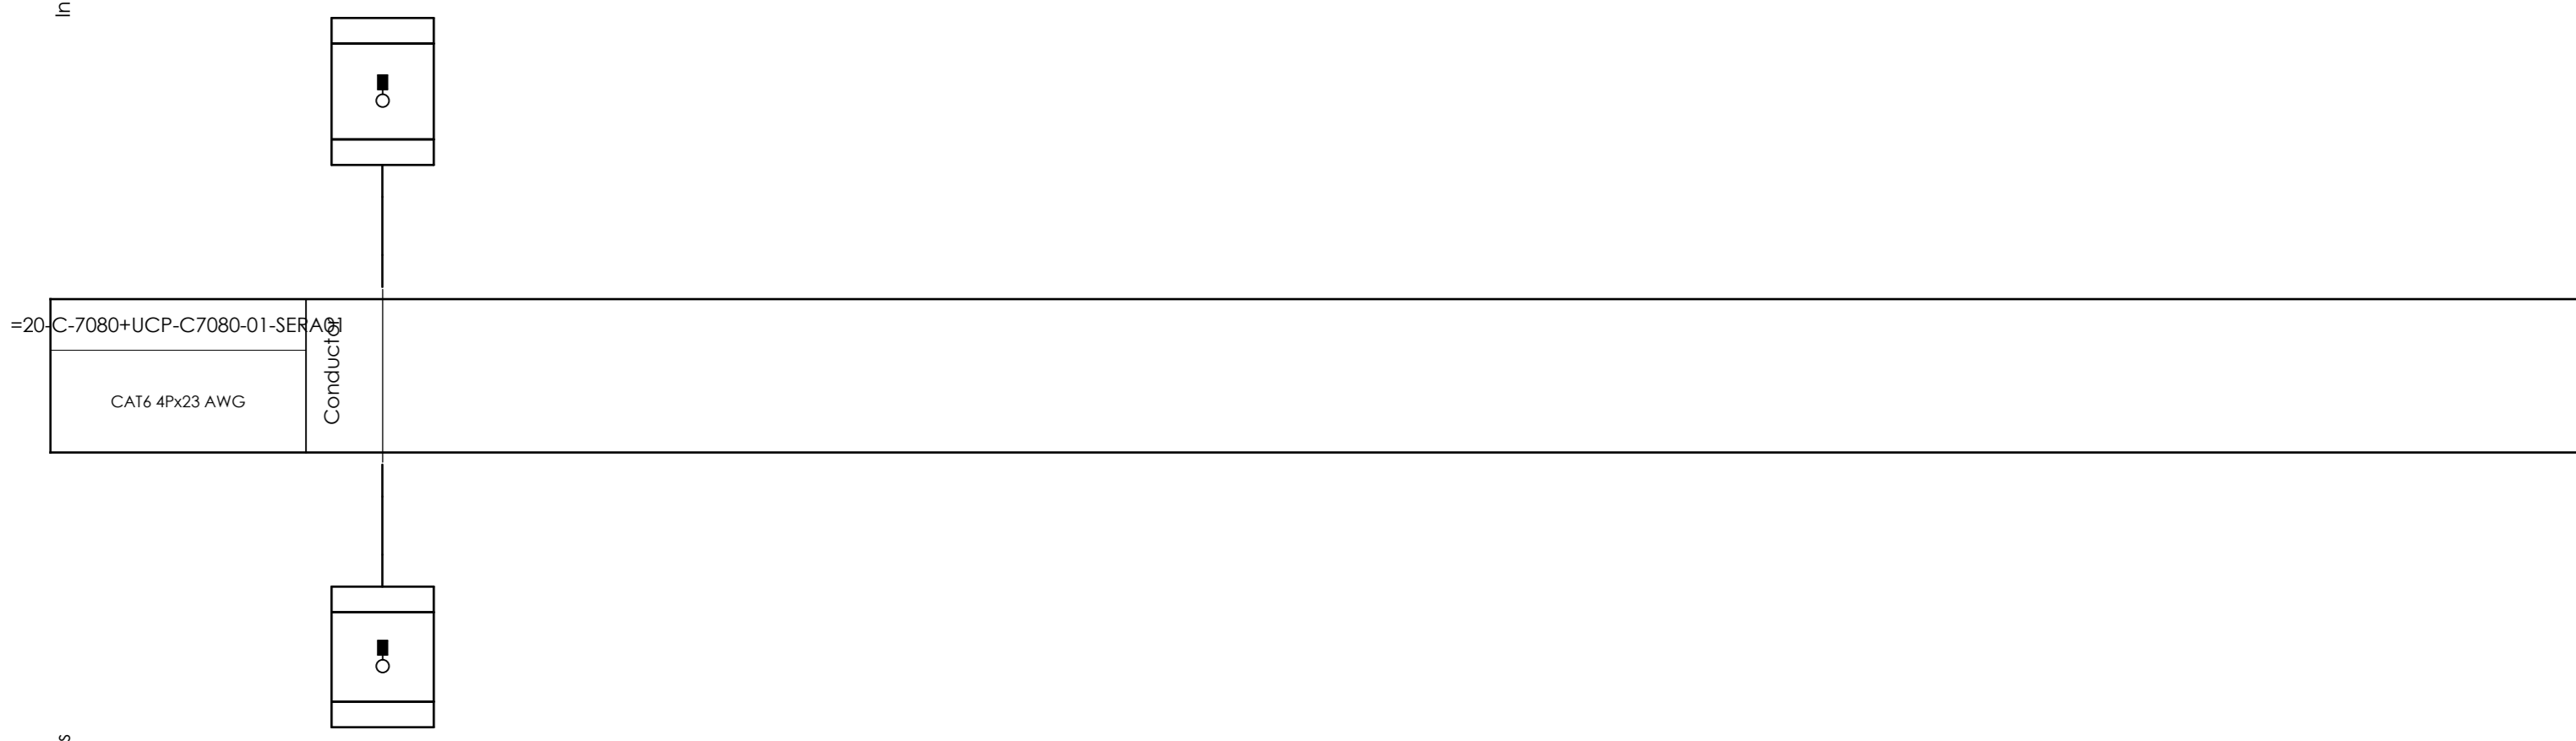

=20-C-7080+UCP-C7080-01-SERA01

CAT6 4Px23 AWG

Conductors

External targets




CLIENT DWG NO.	BU-20-VD-303-IN-DIG-0093
EQUIPMENT NO.	20-C-7080
EQUIPMENT LOCATION	Iran, Onshore
THIS DRAWING IS OWNED BY AIRPACK, AND SHALL NOT BE PRINTED OR COPIED IN ANY OTHER WAY THAN WITH AIRPACKS PERMISSION!	

SUBJECT		Cable-connection diagram =20-C-7080+UCP-C7080-01-SERA01	
ADAPTED TO P&ID REVISION	05	CLIENT	Bushehr Petrochemical Company (BUPC)
AIRPACK REF.	17811-30B	CLIENT REF.	Bushehr MEG Plant Project


DRAWN BY	MaGo
CHECKED BY	RBE
LAST MODIFICATION DATE	
AIRPACK DWG NO.	17811-05B
REVISION	01
TOTAL PAGE AMOUNT	12

=	
+	
CURRENT PAGE	

Internal targets

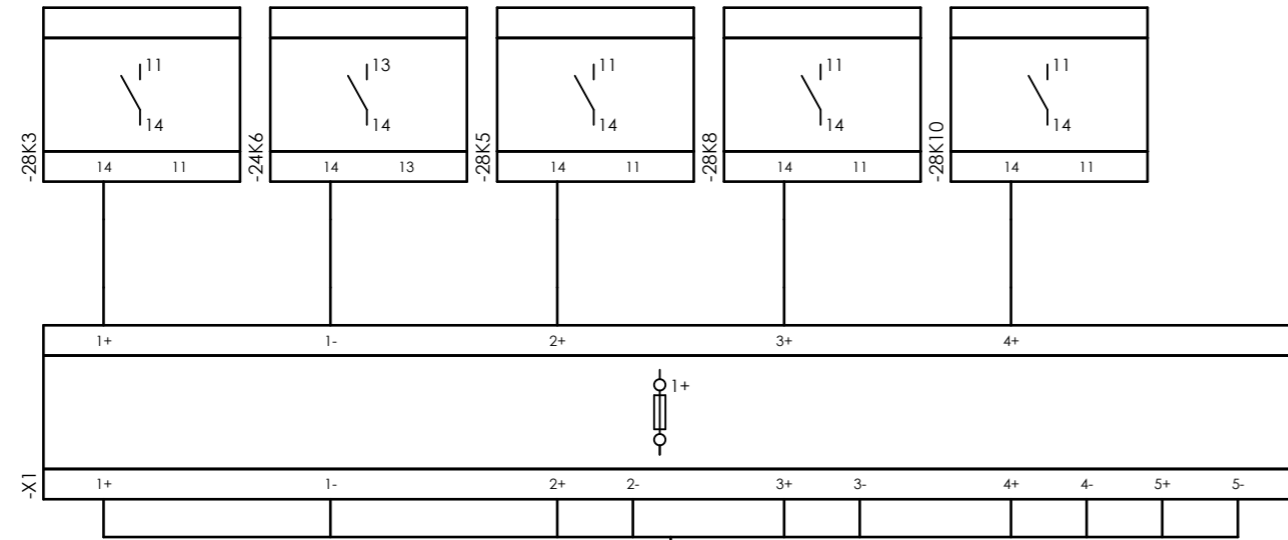

External targets

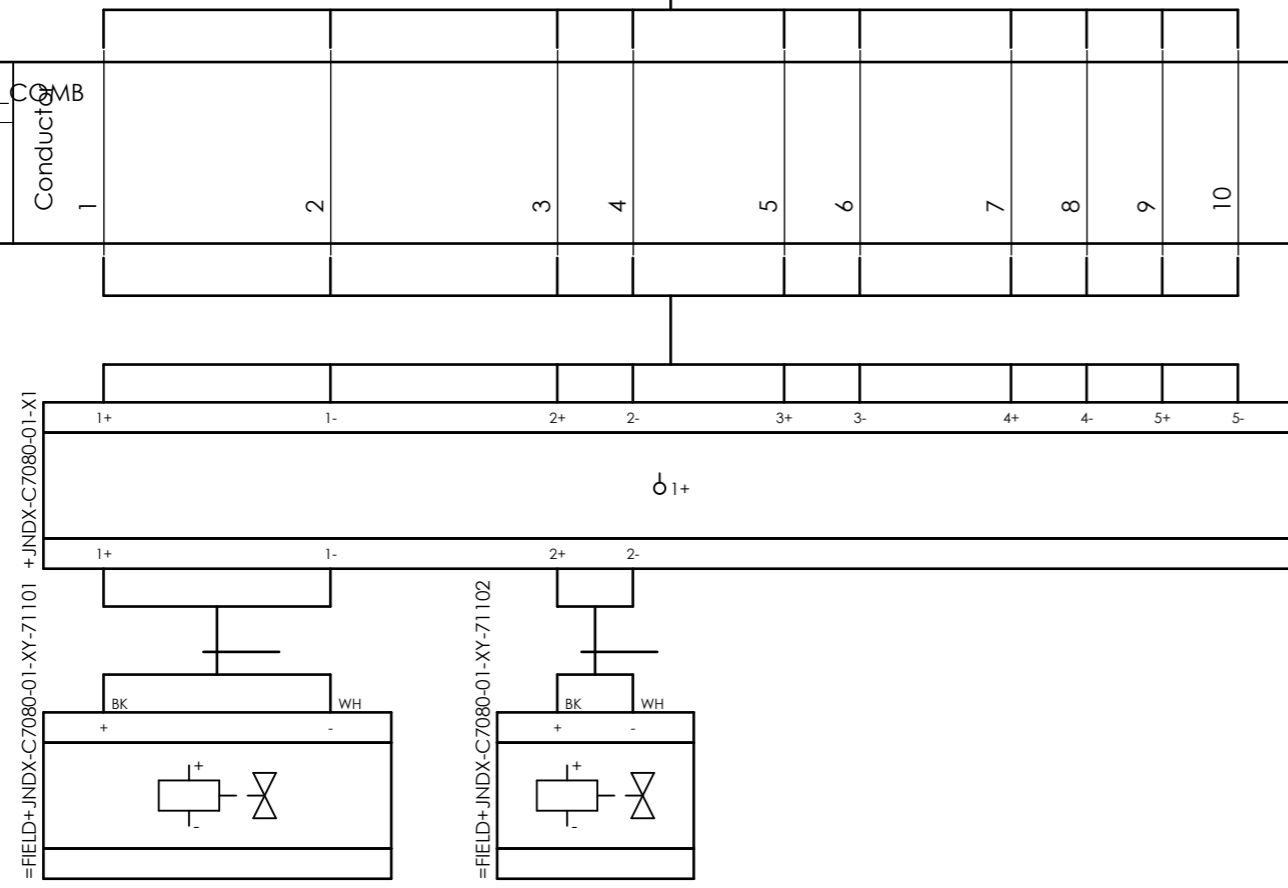


CLIENT DWG NO. BU-20-VD-303-IN-DIG-0093
 EQUIPMENT NO. 20-C-7080
 EQUIPMENT LOCATION Iran, Onshore
 THIS DRAWING IS OWNED BY AIRPACK, AND SHALL NOT BE PRINTED OR COPIED IN ANY OTHER WAY THAN WITH AIRPACKS PERMISSION!

SUBJECT Cable-connection diagram =20-C-7080+UCP-C7080-01-SOL_COMB
 ADAPTED TO P&ID REVISION 05
 CLIENT Bushehr Petrochemical Company (BUPC)
 CLIENT REF. Bushehr MEG Plant Project
 AIRPACK REF. 17811-30B


DRAWN BY MaGo
 CHECKED BY RBE
 LAST MODIFICATION DATE
 AIRPACK DWG NO. 17811-05B
 REVISION 01
 TOTAL PAGE AMOUNT 13

=
 +
 CURRENT PAGE
 13


Internal targets

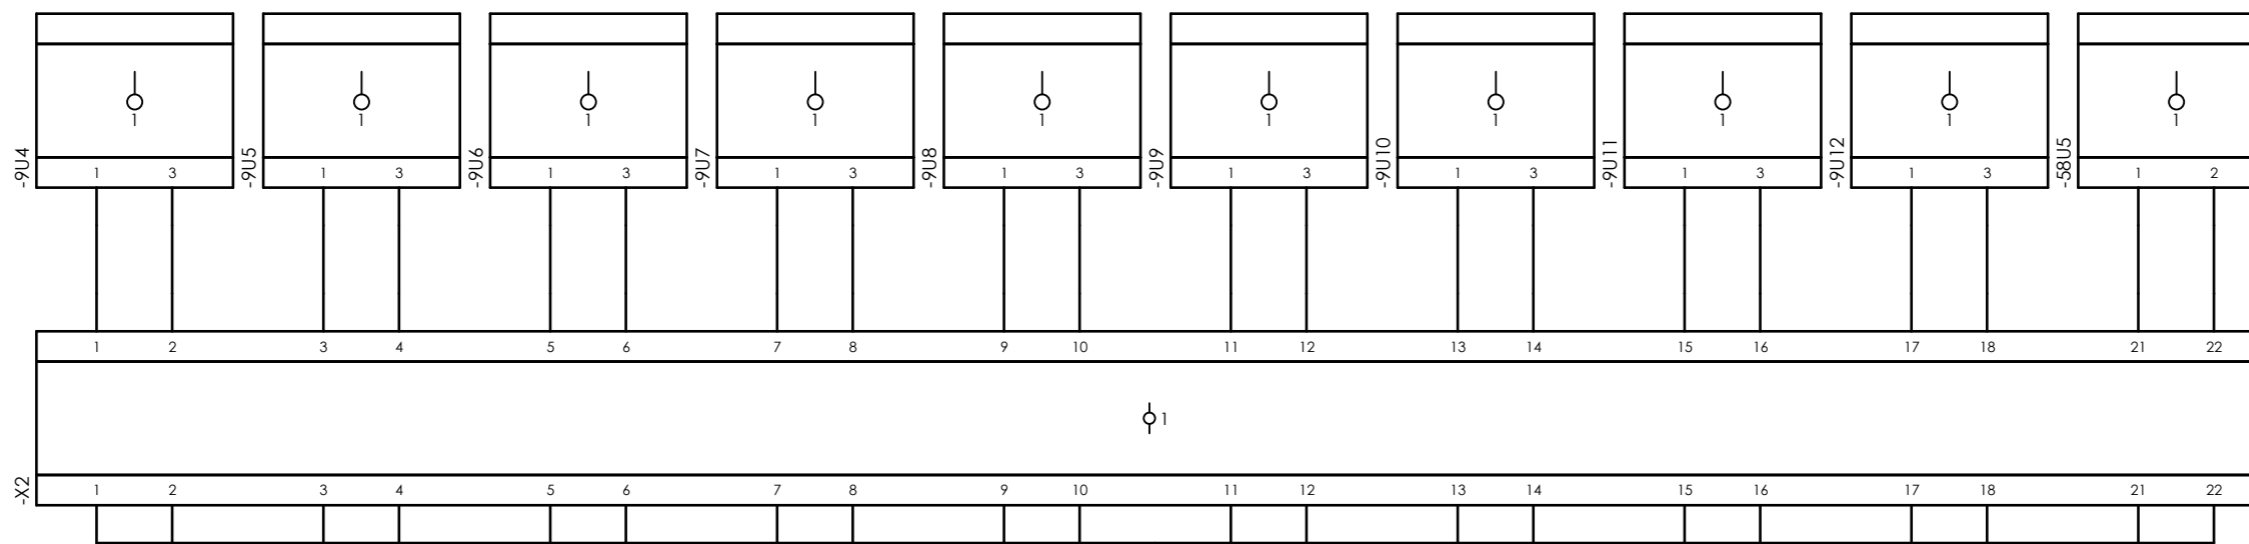

=20-C-7080+UCP-C7080-01-TR_COMB

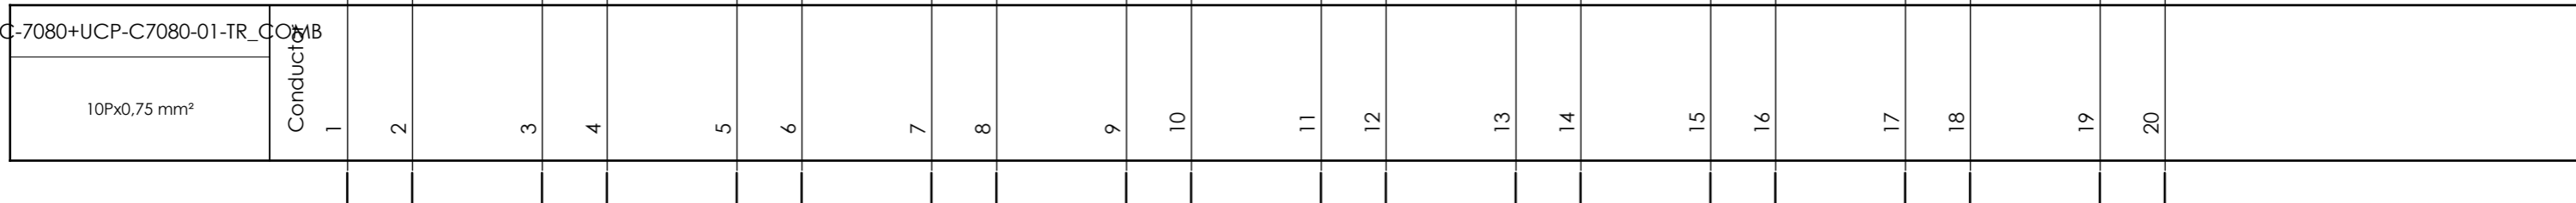

External targets

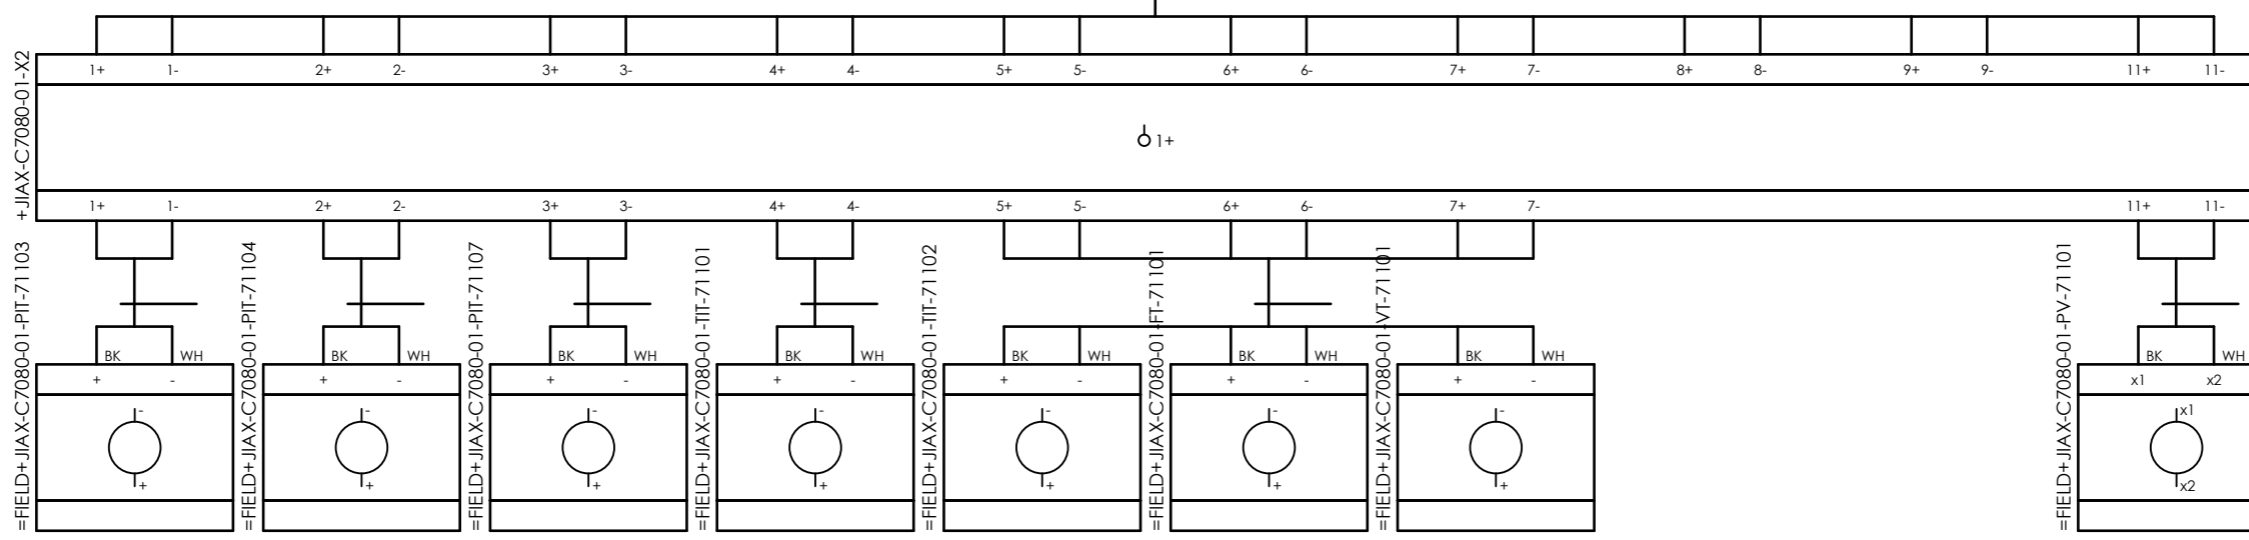



CLIENT DWG NO.	BU-20-VD-303-IN-DIG-0093
EQUIPMENT NO.	20-C-7080
EQUIPMENT LOCATION	Iran, Onshore
THIS DRAWING IS OWNED BY AIRPACK, AND SHALL NOT BE PRINTED OR COPIED IN ANY OTHER WAY THAN WITH AIRPACKS PERMISSION!	

SUBJECT	
Cable-connection diagram =20-C-7080+UCP-C7080-01-TR_COMB	
ADAPTED TO P&ID REVISION	05
CLIENT	Bushehr Petrochemical Company (BUPC)
CLIENT REF.	Bushehr MEG Plant Project
AIRPACK REF.	17811-30B


DRAWN BY	MaGo
CHECKED BY	RBE
LAST MODIFICATION DATE	
AIRPACK DWG NO.	17811-05B
REVISION	01
TOTAL PAGE AMOUNT	14

=	
+	
CURRENT PAGE	

 
Internal targets

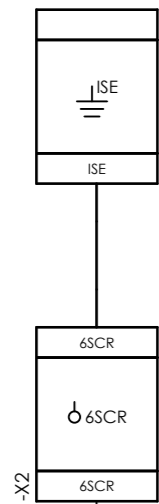

=20-C-7080+JIAX-C7080-01-FT-71101

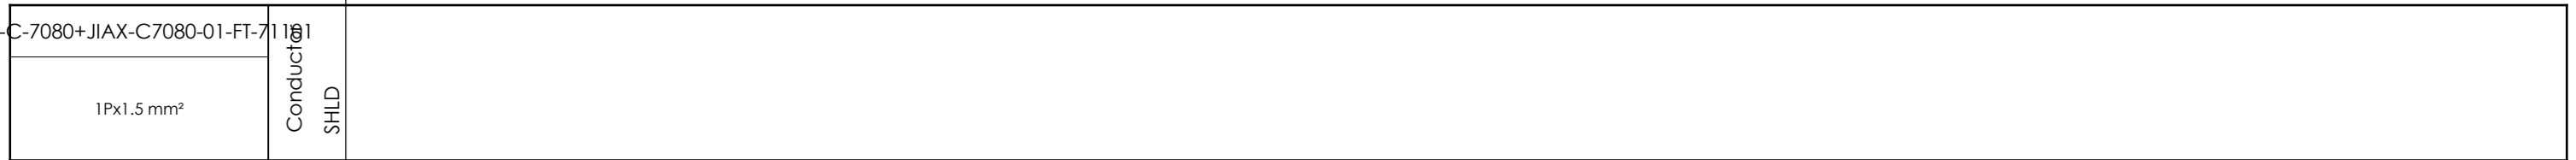

Conductor
SHLD

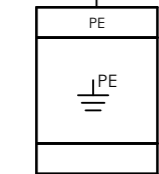

External targets




CLIENT DWG NO.	BU-20-VD-303-IN-DIG-0093
EQUIPMENT NO.	20-C-7080
EQUIPMENT LOCATION	Iran, Onshore
THIS DRAWING IS OWNED BY AIRPACK, AND SHALL NOT BE PRINTED OR COPIED IN ANY OTHER WAY THAN WITH AIRPACKS PERMISSION!	

SUBJECT Cable-connection diagram =20-C-7080+JIAX-C7080-01-FT-71101	
ADAPTED TO P&ID REVISION	05
CLIENT	Bushehr Petrochemical Company (BUPC)
CLIENT REF.	Bushehr MEG Plant Project
AIRPACK REF.	17811-30B


DRAWN BY	MaGo
CHECKED BY	RBE
LAST MODIFICATION DATE	
AIRPACK DWG NO.	17811-05B
REVISION	01
TOTAL PAGE AMOUNT	15

=
+
CURRENT PAGE

Internal targets

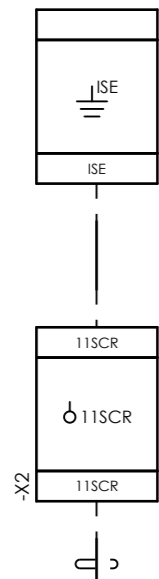

External targets

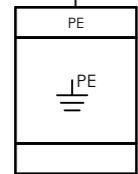


CLIENT DWG NO.	BU-20-VD-303-IN-DIG-0093
EQUIPMENT NO.	20-C-7080
EQUIPMENT LOCATION	Iran, Onshore
THIS DRAWING IS OWNED BY AIRPACK, AND SHALL NOT BE PRINTED OR COPIED IN ANY OTHER WAY THAN WITH AIRPACKS PERMISSION!	

SUBJECT		Cable-connection diagram =20-C-7080+JIAX-C7080-01-PV-71101	
ADAPTED TO P&ID REVISION	05	CLIENT	Bushehr Petrochemical Company (BUPC)
CLIENT REF.	Bushehr MEG Plant Project	AIRPACK REF.	17811-30B

DRAWN BY	MaGo
CHECKED BY	RBE
LAST MODIFICATION DATE	
AIRPACK DWG NO.	17811-05B
REVISION	01
TOTAL PAGE AMOUNT	16


=
+
CURRENT PAGE

Internal targets

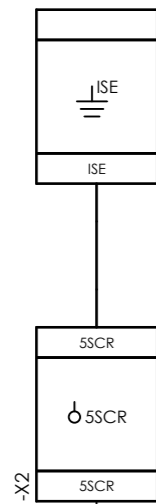


X2

=20-C-7080+JIAX-C7080-01-TIT-71102

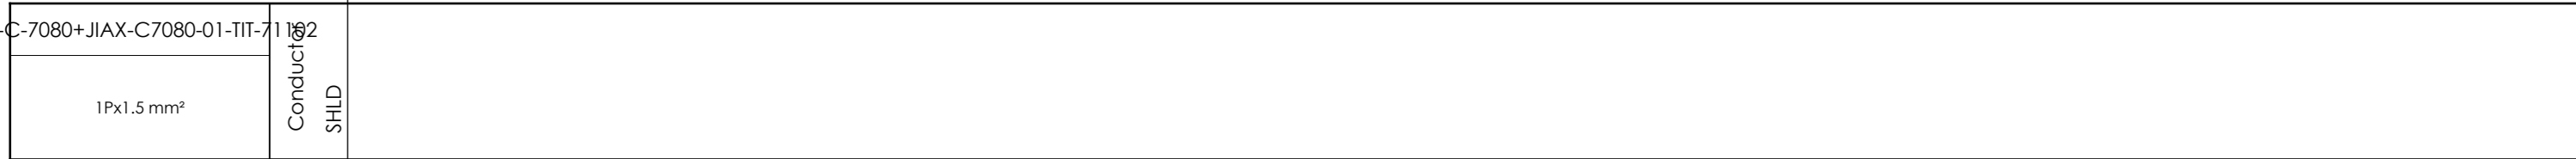

X2

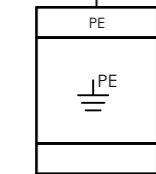

External targets





CLIENT DWG NO.	BU-20-VD-303-IN-DIG-0093
EQUIPMENT NO.	20-C-7080
EQUIPMENT LOCATION	Iran, Onshore
THIS DRAWING IS OWNED BY AIRPACK, AND SHALL NOT BE PRINTED OR COPIED IN ANY OTHER WAY THAN WITH AIRPACKS PERMISSION!	

SUBJECT		Cable-connection diagram =20-C-7080+JIAX-C7080-01-TIT-71102	
ADAPTED TO P&ID REVISION	05	CLIENT	Bushehr Petrochemical Company (BUPC)
AIRPACK REF.	17811-30B	CLIENT REF.	Bushehr MEG Plant Project



DRAWN BY	MaGo
CHECKED BY	RBE
LAST MODIFICATION DATE	
AIRPACK DWG NO.	17811-05B
REVISION	01
TOTAL PAGE AMOUNT	17

=
+
CURRENT PAGE

 Internal targets

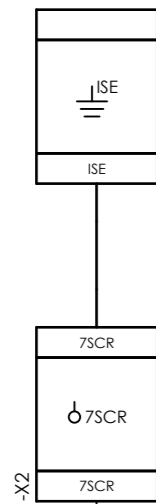

=20-C-7080+JIAX-C7080-01-VT-71101

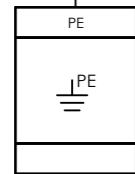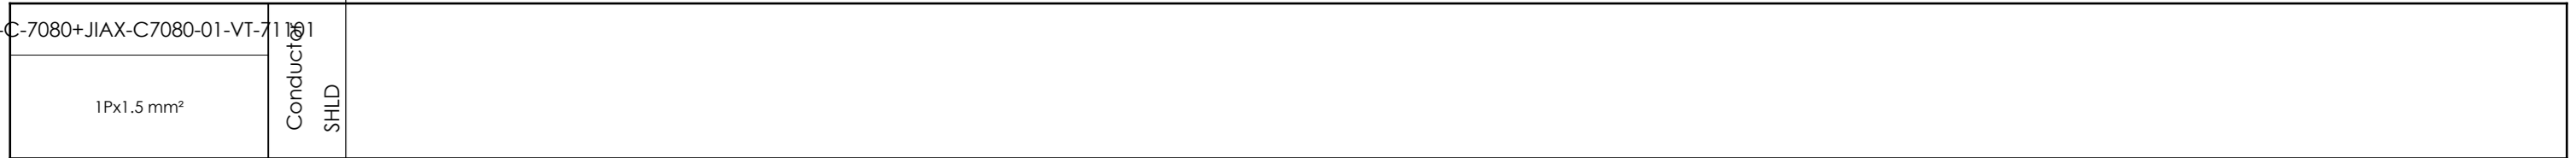

External targets




CLIENT DWG NO.	BU-20-VD-303-IN-DIG-0093
EQUIPMENT NO.	20-C-7080
EQUIPMENT LOCATION	Iran, Onshore
THIS DRAWING IS OWNED BY AIRPACK, AND SHALL NOT BE PRINTED OR COPIED IN ANY OTHER WAY THAN WITH AIRPACKS PERMISSION!	



SUBJECT		Cable-connection diagram =20-C-7080+JIAX-C7080-01-VT-71101	
ADAPTED TO P&ID REVISION	05	CLIENT	Bushehr Petrochemical Company (BUPC)
CLIENT REF.	Bushehr MEG Plant Project	AIRPACK REF.	17811-30B

DRAWN BY	MaGo	=
CHECKED BY	RBE	+
LAST MODIFICATION DATE		CURRENT PAGE
AIRPACK DWG NO.	17811-05B	
REVISION	01	
TOTAL PAGE AMOUNT	18	

Internal targets

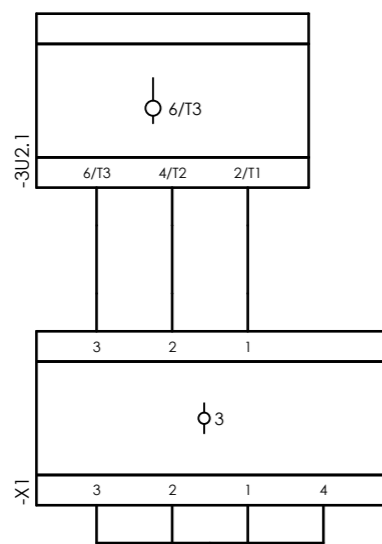

External targets

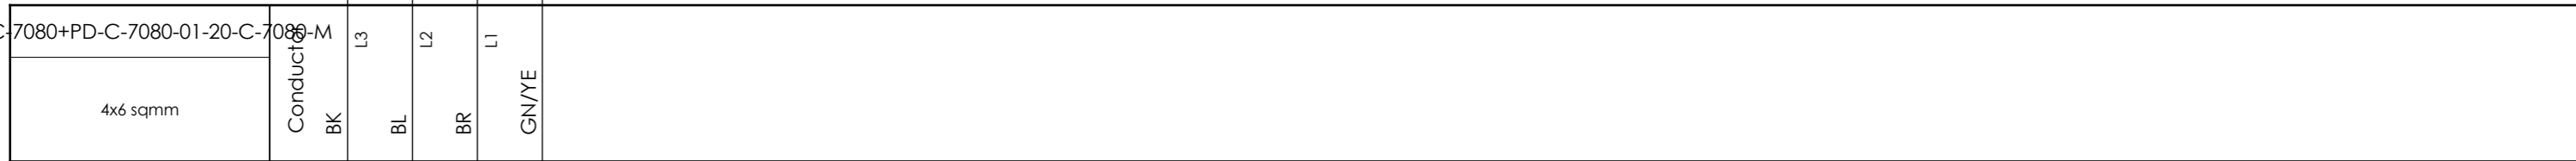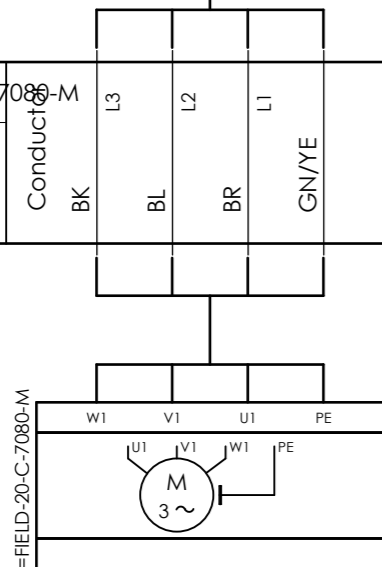


CLIENT DWG NO.	BU-20-VD-303-IN-DIG-0093
EQUIPMENT NO.	20-C-7080
EQUIPMENT LOCATION	Iran, Onshore
THIS DRAWING IS OWNED BY AIRPACK, AND SHALL NOT BE PRINTED OR COPIED IN ANY OTHER WAY THAN WITH AIRPACKS PERMISSION!	

SUBJECT		Cable-connection diagram =20-C-7080+PD-C-7080-01-20-C-7080-M	
ADAPTED TO P&ID REVISION	05	CLIENT	Bushehr Petrochemical Company (BUPC)
CLIENT REF.	Bushehr MEG Plant Project	AIRPACK REF.	17811-30B


DRAWN BY	MaGo
CHECKED BY	RBE
LAST MODIFICATION DATE	
AIRPACK DWG NO.	17811-05B
REVISION	01
TOTAL PAGE AMOUNT	19

=	
+	
CURRENT PAGE	

Internal targets

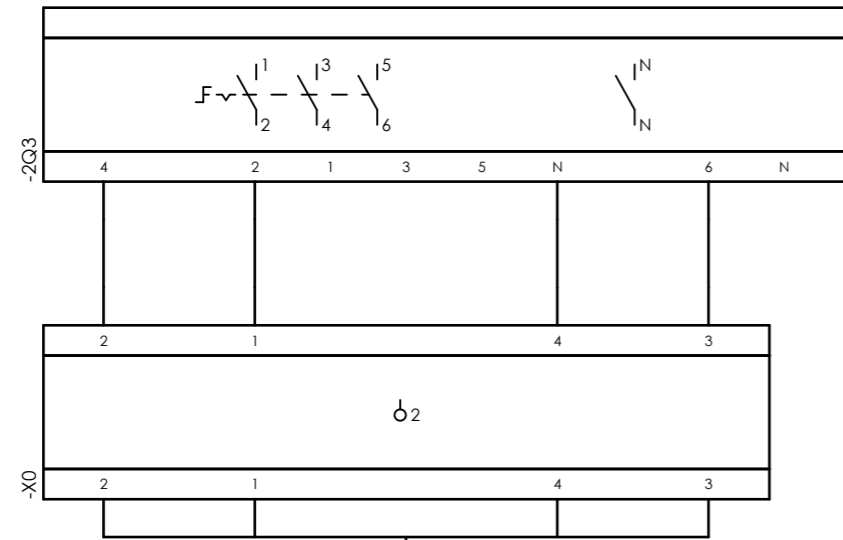


External targets

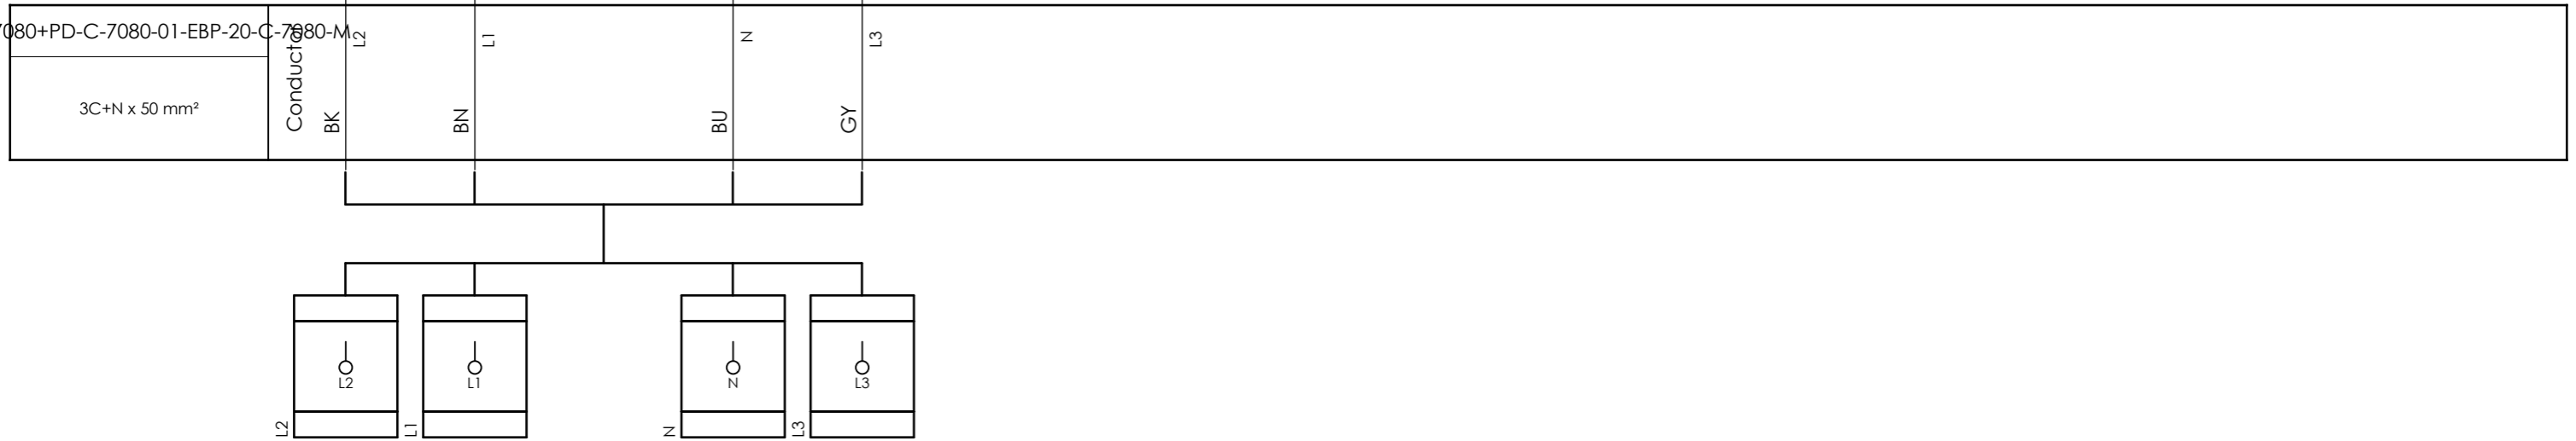

CLIENT DWG NO.	BU-20-VD-303-IN-DIG-0093
EQUIPMENT NO.	20-C-7080
EQUIPMENT LOCATION	Iran, Onshore
THIS DRAWING IS OWNED BY AIRPACK, AND SHALL NOT BE PRINTED OR COPIED IN ANY OTHER WAY THAN WITH AIRPACKS PERMISSION!	

SUBJECT		DRAWN BY	MaGo	=
Cable-connection diagram =20-C-7080+PD-C-7080-01-EBP-20-C-7080-M		CHECKED BY	RBE	+
ADAPTED TO P&ID REVISION	05	LAST MODIFICATION DATE		CURRENT PAGE
CLIENT	Bushehr Petrochemical Company (BUPC)	AIRPACK DWG NO.	17811-05B	
CLIENT REF.	Bushehr MEG Plant Project	REVISION	01	
AIRPACK REF.	17811-30B	TOTAL PAGE AMOUNT	20	


Internal targets

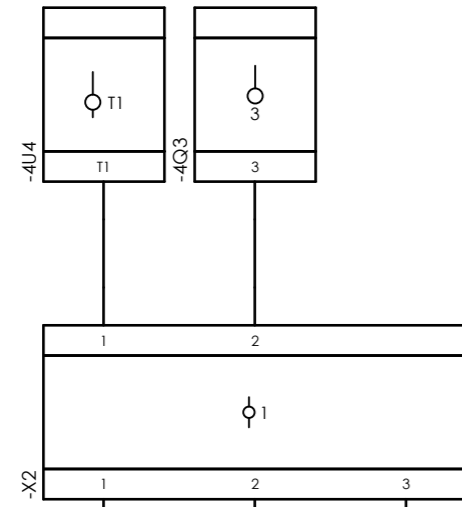

=20-C-7080+PD-C-7080-01-LG-71101



External targets

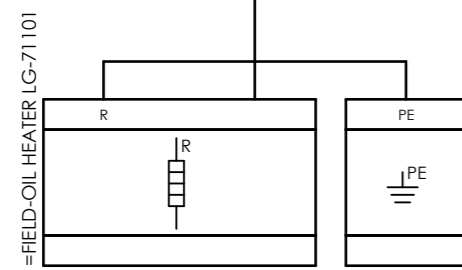

CLIENT DWG NO.	BU-20-VD-303-IN-DIG-0093
EQUIPMENT NO.	20-C-7080
EQUIPMENT LOCATION	Iran, Onshore
THIS DRAWING IS OWNED BY AIRPACK, AND SHALL NOT BE PRINTED OR COPIED IN ANY OTHER WAY THAN WITH AIRPACKS PERMISSION!	

SUBJECT		Cable-connection diagram =20-C-7080+PD-C-7080-01-LG-71101	
ADAPTED TO P&ID REVISION	05	CLIENT	Bushehr Petrochemical Company (BUPC)
AIRPACK REF.	17811-30B	CLIENT REF.	Bushehr MEG Plant Project

DRAWN BY	MaGo
CHECKED BY	RBE
LAST MODIFICATION DATE	
AIRPACK DWG NO.	17811-05B
REVISION	01
TOTAL PAGE AMOUNT	21

=	
+	
CURRENT PAGE	

